

NOTE: PIPE ENTRY/EXIT SHALL MATCH JCW PERMITTED SITE PLAN.

* SHOW ONLY PIPE ARRANGEMENT REQUIRED FOR SPECIFIC PROJECT INSTALLATION.


ITEM	DESCRIPTION
1	4" ABS INLET PIPE*
2	4"x4"x2" TEE WITH 2" PIPE TO BUILDING VENT*
3	THREADED C/O CAP JOSAM 58860 OR APP EQUAL**
4	CONCRETE PAD
5	4"x4"x4" TWO-WAY CLEANOUT TEE*
6	4" ABS OUTLET*
7	4" - 6" GRAVEL BEDDING
8	HEAVY-DUTY CAST IRON FRAME AND COVER ***
9	CONCRETE ADJUSTMENT RINGS
10	REINFORCE AS REQUIRED FOR SERVICE CONDITIONS
11	4" ABS 90° ELBOW*
12	4" ABS TEE*
13	A-LOK OR PRESS SEAL PSX PIPE/WALL CONNECTOR
14	2" VENT PIPE
(F) 15	STAINLESS STEEL PIPE SUPPORT CLAMP ****

* 6" PIPE MAY BE SUBSTITUED TO MATCH UPSTREAM PIPE DIAMETER.

** REFER TO CLEAN OUT DETAIL(S) ON STANDARD DETAIL SHEET.

*** CLAY & BAILEY 2008 BV OR EQUAL (FROST PROOF COVERS OPTIONAL)

(F) ****FM STAINLESS FASTNERS #63 OR EQUAL. 1/2"x2-1/2" SS BRACKET W/ 1/2"x1-1/2" FULLY THREADED SS HEX BOLT WITH 1/2" SS WASHER AND 1/2"x1-3/4" SS ANCHORS. CLAMP TO BE FACTORY INSTALLED.

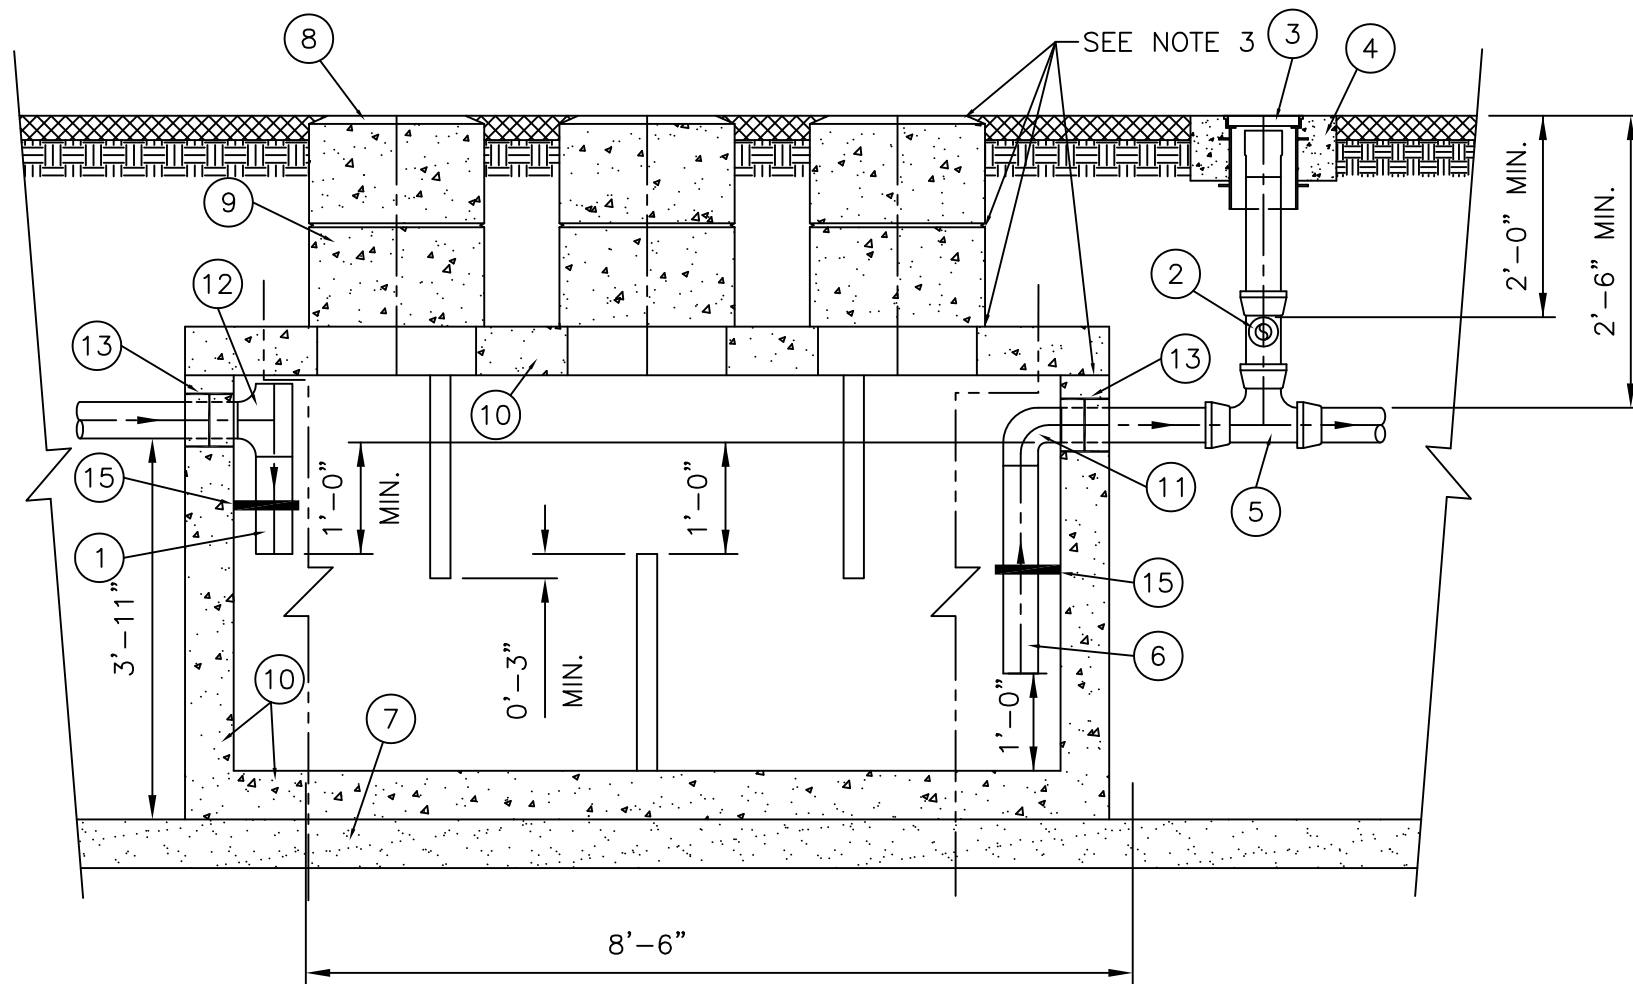

NOTES:

- THREE COVERS AND RISERS SHOWN. TWO COVERS AND RISERS CENTERED OVER UPPER TWO BAFFLES ARE OPTIONAL.
- (B) INTERCEPTOR SIZE - 1000 GAL MINIMUM (REVISE THE SIZE DIMENSIONS, AS NEEDED, FOR LARGER CAPACITY INTERCEPTORS)
- (D) ALL JOINTS AT THE FRAME & COVER*, CONCRETE ADJUSTMENT RINGS AND THE LID OF THE INTERCEPTOR SHALL BE SEALED WITH A MINIMUM OF TWO (2) ROWS OF 3/4 TO 1 INCH PREFORMED BUTYL JOINT SEALER AND A 6" BUTYL JOINT WRAP AROUND SLEEVE (EZ WRAP). THE ENDS OF THE 6" EZ WRAP SHALL OVERLAP BY 12".
- (B) PIPING ON THE INTERIOR OF THE INTERCEPTOR SHALL BE ABS WITH SOLVENT-CEMENTED JOINTS.
- (C)(D)(E) GREASE INTERCEPTOR INCLUDING ADJUSTMENT RINGS AND CASTINGS SHALL BE VACUUM TESTED FOR WATER TIGHTNESS AFTER THE BACKFILL OPERATIONS HAVE BEEN COMPLETED IN ACCORDANCE WITH JCW TECHNICAL SPECIFICATIONS. A VACUUM OF 10 INCHES OF MERCURY SHALL BE DRAWN AND WITH THE VACUUM PUMP SHUT OFF THE MERCURY SHALL NOT DROP BELOW 9 INCHES WITHIN 1 MINUTE OR BELOW 5 INCHES WITHIN 5 MINUTES.



11811 S. SUNSET DRIVE, STE 2500
OLATHE, KS 66061
Phone : (913) 715-8500
Fax : (913) 715-8501

Drawn: K. FIGGE	Date: 8/10/06	Scale: N.T.S.
Checked: J. HARDER	Date: 8/10/06	Project # 0001
Approved: J. METZLER	Date: 8/10/06	Sheet: 1 of 1
Title: SAND/OIL INTERCEPTOR 1000 GALLON		
Project : JOHNSON COUNTY WASTEWATER STANDARD DRAWING		

NO.	BY	DATE	REVISION
F	KWF	09/01/11	ADDED ITEM #15 - SS PIPE SUPPORT CLAMP
E	KWF	08/17/10	REVISED NOTE 5
D	WLM	7/29/10	REVISED NOTES 3 AND 5
C	WLM	7/14/08	ADDED NOTE 5
B	KWF	7/21/06	CHANGED ITEMS IN MTRL BOX & NOTE 2 & ADDED NOTE 4
A	JSD	10/29/04	DIMENSION CHANGE BY REQUEST OF JCW